

WALL TYPE LEGEND

- GYPSUM BOARD TO CEILING EA. SIDE OF WOOD STUDS @ 16" O.C TO BOTTOM OF STRUCTURE ABOVE W/ INSULATION
- GYPSUM BOARD TO CEILING EX. SIDE OF WOOD STUDS @ 16" O.C TO BOTTOM OF STRUCTURE ABOVE
- GYPSUM BOARD TO CEILING ONE SIDE OF WOOD STUDS @ 16" O.C TO BOTTOM OF STRUCTURE ABOVE W/ INSULATION
- 1 HOUR FIRE-RATED WALL, GYPSUM BOARD EA. SIDE TO ROOF DECK OF WOOD STUDS @ 16" O.C. TO BOTTOM OF ROOF DECK ABOVE W/ INSULATION. SEAL ALL PENETRATIONS W/ FIRE SEALANT
- 3/4" PLYWOOD TO CEILING EA. SIDE OF WOOD STUDS @ 16" O.C TO BOTTOM OF STRUCTURE ABOVE
- CMU TO STRUCTURE ABOVE
- BRICK VENEER O/ AIRSPACE W/ CAVITY DRAINAGE MAT O/ EXTERIOR SHEATHING O/ WOOD STUDS @ 16" O.C. W/ INSULATION AND GYPSUM BOARD ON INTERIOR TO CEILING


GENERAL FLOOR PLAN NOTES

1. FIELD VERIFY ALL DIMENSIONS AND CONDITIONS PRIOR TO EXECUTING ANY WORK. NOTIFY ARCHITECT OF ANY DIMENSIONS OR WORK DIFFERING FROM THAT SHOWN, FOR CLARIFICATION BY THE ARCHITECT PRIOR TO PROCEEDING WITH WORK.
2. VERIFY ALL ROUGH OPENINGS FOR DOORS, WINDOWS, EQUIPMENT, & OTHER 'BUILT-IN' ITEMS PRIOR TO EXECUTION OF ANY WORK AFFECTED BY SAME.
3. LOCATE DOOR OPENINGS WHICH ARE NOT DIMENSIONED OTHERWISE, CENTERED IN WALL AND 6" FROM FINISH WALL TO FINISH JAMB.
4. COORDINATE ALL FLOOR DRAINS AND OTHER REFERENCED MECHANICAL, ELECTRICAL, OR PLUMBING ITEMS W/ M.E.P.
5. COORDINATE ALL REQUIRED UTILITIES WITH EQUIPMENT MANUFACTURER.
6. ALL DIMENSIONS ARE TO FACE OF STUD - OR MASONRY - UNLESS OTHERWISE NOTED.
7. DO NOT SCALE DRAWINGS - WHERE DIMENSIONAL DISCREPANCIES ARE ENCOUNTERED NOTIFY ARCHITECT PRIOR TO PROCEEDING WITH THE WORK.
8. COORDINATE HEIGHTS OF OUTLETS & SWITCHING WITH ALL ARCHITECTURAL ITEMS. SEE M/E DRAWINGS FOR LOCATIONS.
9. COORDINATE INTERIOR SHEAR WALL LOCATIONS AND CONSTRUCTION WITH STRUCTURAL.

PLAN LEGEND

- HEADER / SOFFIT ABOVE
- DRYWALL CONTROL JOINT
- FIRE EXTINGUISHER CABINET
- FLOOR DRAIN
- CONCRETE CONTROL JOINT
- MASONRY VENEER EXPANSION JOINT
- DOWNSPOUT
- KNOX BOX (VERIFY LOCATION W/ OWNER)

Peckham & Wright Architects, Inc.
 Architectural Corporation
 Certificate/License No. 000244
 15 South Tenth Street
 Columbia, Missouri 65201
 Ph: (573) 449-2683 Fax: (573) 442-6213

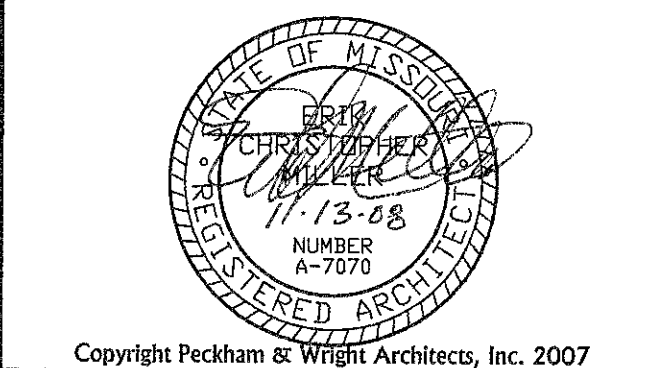

Copyright Peckham & Wright Architects, Inc. 2007

CITY OF COLUMBIA
 FIRE STATION #9
 BLUE RIDGE RD.
 COLUMBIA, MISSOURI

Drawn: CB, JM, MA	Project Number: 200716	
Checked: EM	CAD File Name (Number): A101.DWG	
Drawing Title: FLOOR PLAN		
No.	Revisions:	Date:
Submission Date: 11/12/2008	Drawing Number: A101	
Plot Date: 11/11/2008		

FLOOR PLAN
 SCALE: 3/16" = 1'-0"